


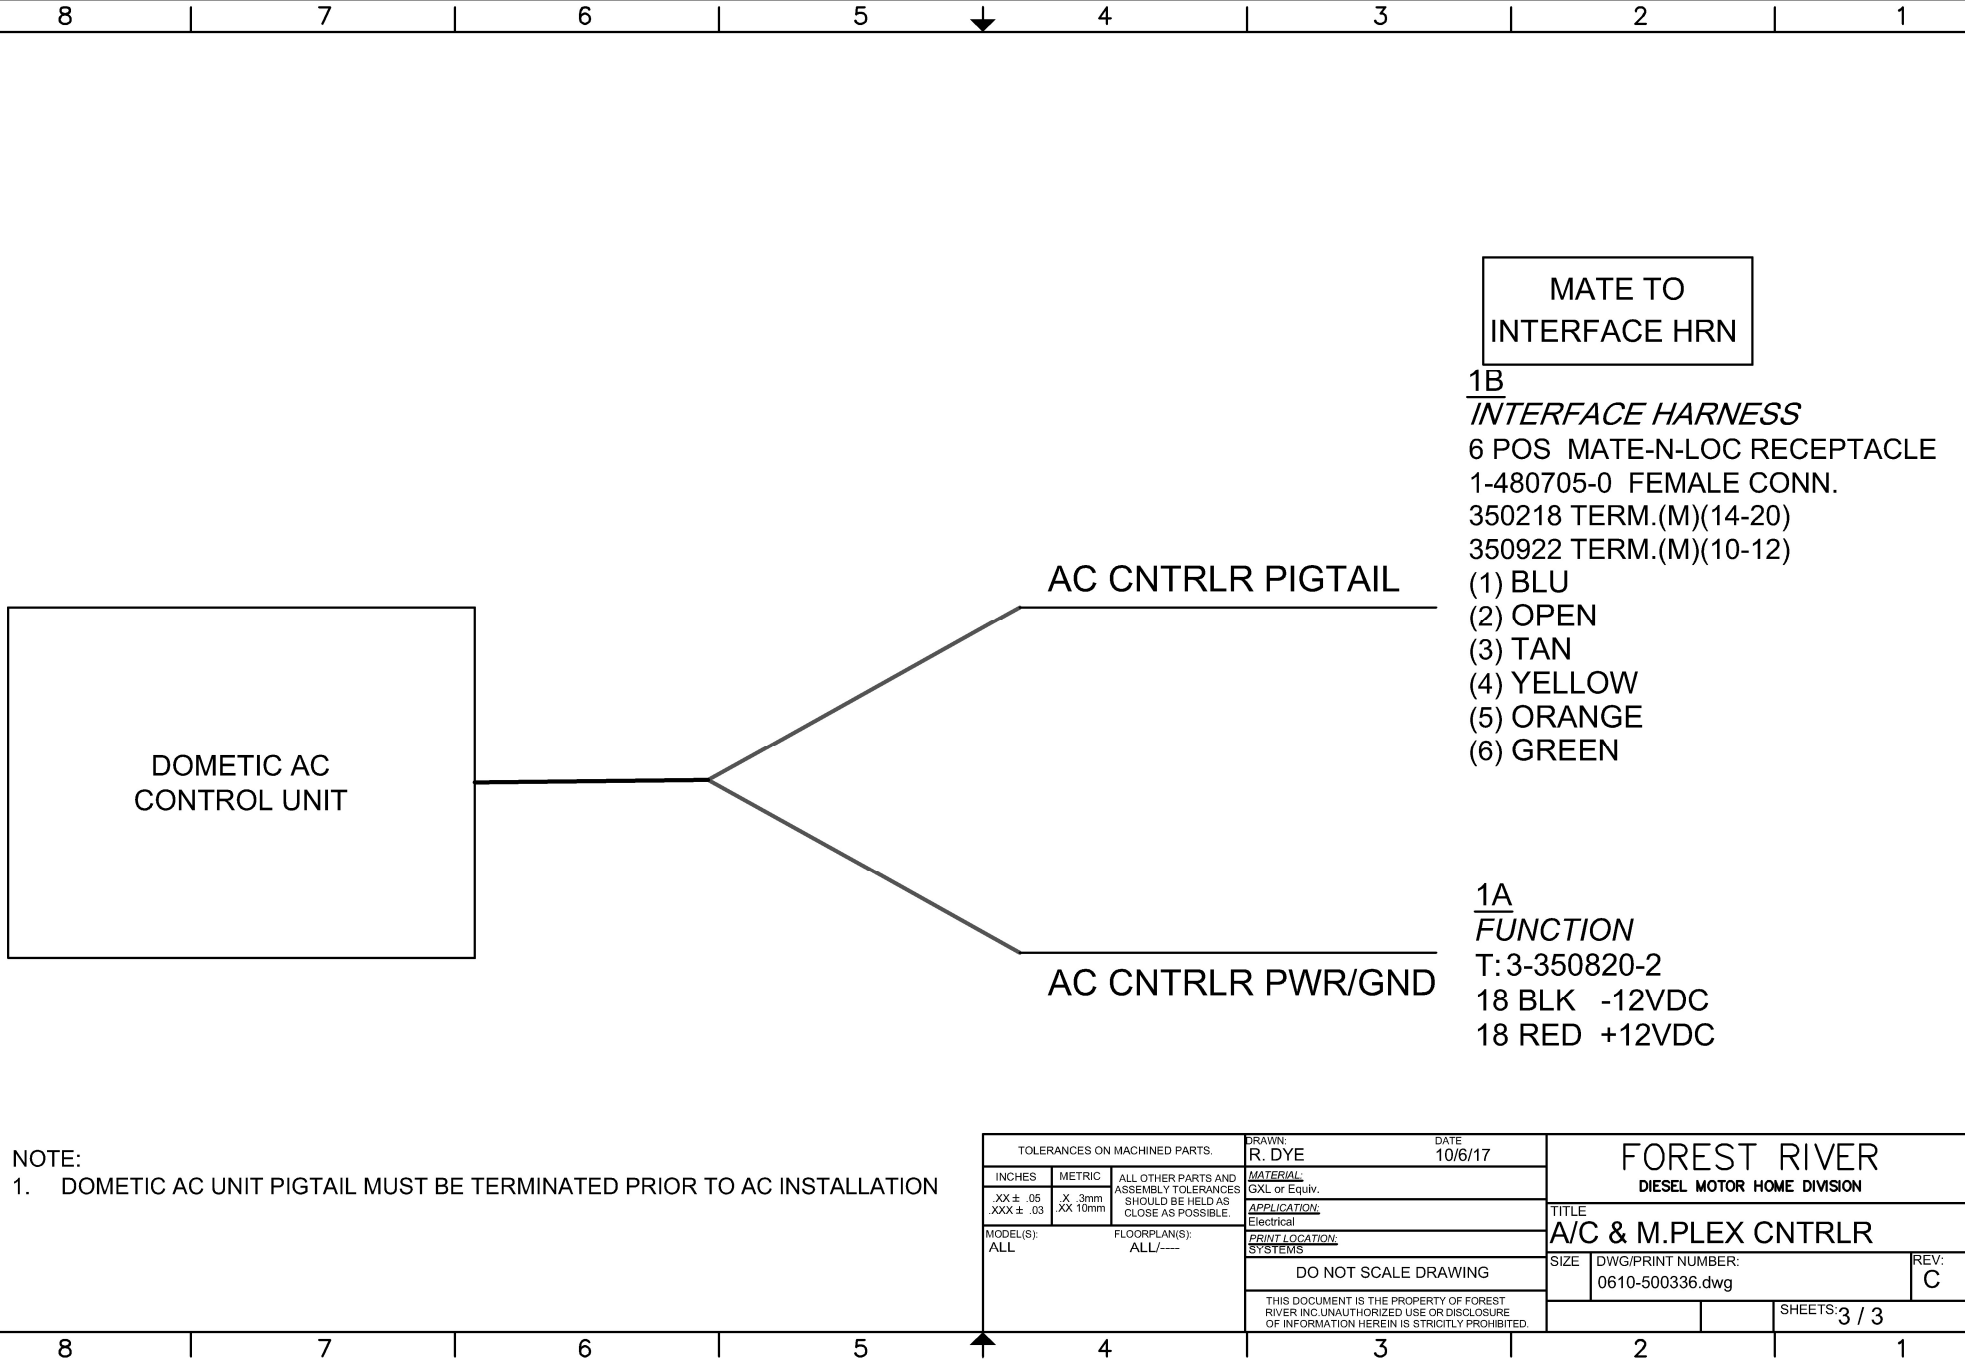

MATE TO
INTERFACE HRN

- 1B
INTERFACE HARNESS
6 POS MATE-N-LOC RECEPTACLE
1-480705-0 FEMALE CONN.
350218 TERM.(M)(14-20)
350922 TERM.(M)(10-12)
(1) BLU
(2) OPEN
(3) TAN
(4) YELLOW
(5) ORANGE
(6) GREEN

- 1A
FUNCTION
T:3-350820-2
18 BLK -12VDC
18 RED +12VDC

NOTE:
1. DOMETIC AC UNIT PIGTAIL MUST BE TERMINATED PRIOR TO AC INSTALLATION


TOLERANCES ON MACHINED PARTS.			DRAWN: R. DYE		DATE 10/6/17		FOREST RIVER	
INCHES	METRIC	ALL OTHER PARTS AND ASSEMBLY TOLERANCES SHOULD BE HELD AS CLOSE AS POSSIBLE.	MATERIAL: GXL or Equiv.		APPLICATION: Electrical		TITLE: A/C & M.PLEX CNTRLR	
.XX ± .05 XXX ± .03	.X .3mm .XX 10mm		PRINT LOCATION: SYSTEMS		DO NOT SCALE DRAWING		SIZE	DWG/PRINT NUMBER: 0610-500336.dwg
MODEL(S): ALL	FLOORPLAN(S): ALL/----		THIS DOCUMENT IS THE PROPERTY OF FOREST RIVER INC. UNAUTHORIZED USE OR DISCLOSURE OF INFORMATION HEREIN IS STRICTLY PROHIBITED.				REV: C	SHEETS: 3 / 3

REVISION			
REV	ECN	DESCRIPTION	AUTHOR
A		NEW FOR MULTIPLEX HVAC	RED
B		REVISE CONTROL TERMINATION	RED
C	1677	ADD AC w/HEAT PUMP HRN	RED

MATE TO
HVAC MODULE

WIRE ENTRY VIEW

2
HVAC MODULE
6-WAY Mini-Fit Jr RECEPTACLE
39-01-2060 MALE CONN.
0039000077 TERM.(F)(16)
0039000038 TERM.(F)(18-24)
(1) 18 GRN (AFH)
(2) OPEN

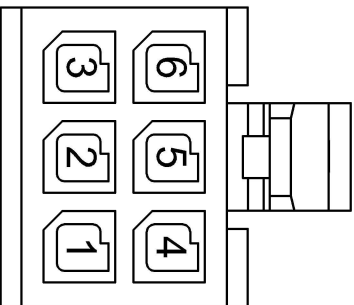

(3) 18 GRAY (AFL)
(4) 18 YEL (CMP)
(5) 18 WHT/BLK (AHT)
(6) 18 BLK (GND)

2'

MATE TO
AC CNTLR

 
1
AC CONTROL
6 POS MATE-N-LOC PLUG
1-480704-0 MALE CONN.
350536 TERM.(F)(14-20)
(1) 18 GRN (AFH)
(2) OPEN
(3) 18 GRAY (AFL)
(4) 18 YEL (CMP)
(5) 18 WHT/BLK (AHT)
(6) 18 BLK (GND)

USAGE:

1 HARNESS PER AC ONLY UNIT
LEGACY, BERKSHIRE, BERKSHIRE XL & BERKSHIRE XLT

NOTE:

1. ALL WIRE TO BE GXL OR EQUIVILENT.
2. ALL SPLICES TO BE COVERED WITH APPROPRIATE HEAT SHRINK.
3. "WHITE"  LOOM SIGNIFIES LOW TEMP TUBING REQUIREMENT.
4. "BLUE"  LOOM SIGNIFIES HIGH TEMP TUBING REQUIREMENT.
5. HARNESS LENGTHS ARE IN FEET UNLESS NOTED WITH QUOTATION FOR INCHES.
7.  TAG HARNESS WITH MODEL AND PART NUMBER.
8. ²⁶/₁₆ FLAT PHONE POSITIONS (1) BLU(2)YEL(3)GRN(4)RED(5)BLK(6)WHT




TOLERANCES ON MACHINED PARTS.			DRAWN:	DATE
INCHES	METRIC	ALL OTHER PARTS AND ASSEMBLY TOLERANCES SHOULD BE HELD AS CLOSE AS POSSIBLE.	R. DYE	12/1/17
.XX ± .05 XXX ± .03	.X .3mm .XX 10mm		MATERIAL: GXL or Equiv.	
MODEL(S): ALL	FLOORPLAN(S): ALL/-----	APPLICATION: Electrical	PRINT LOCATION: SYSTEMS	
DO NOT SCALE DRAWING			THIS DOCUMENT IS THE PROPERTY OF FOREST RIVER INC. UNAUTHORIZED USE OR DISCLOSURE OF INFORMATION HEREIN IS STRICTLY PROHIBITED	
TITLE A/C & M.PLEX STD HRN			SIZE DWG/PRINT NUMBER: 0610-500336.dwg	REV: C

REVISION			
REV	ECN	DESCRIPTION	AUTHOR
A		New Evap Thermostat Harness	RED

MATE TO
HVAC MODULE

WIRE ENTRY VIEW

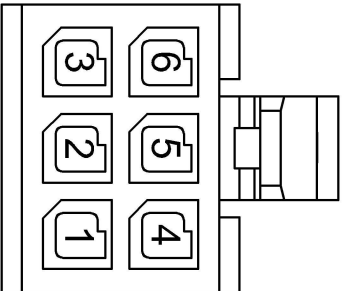

- 2**
HVAC MODULE
6-WAY Mini-Fit Jr RECEPTACLE
39-01-2060 MALE CONN.
0039000077 TERM.(F)(16)
0039000038 TERM.(F)(18-24)
(1) 18 GRN (AFH)
(2) OPEN
(3) 18 GRAY (AFL)
(4) 18 YEL/RED (CMPREQ)
(5) 18 WHT/BLK (AHT)
(6) 18 BLK (GND)

6"

18"

MATE TO
AC CNTLR

- 1**
AC CONTROL
6 POS MATE-N-LOC PLUG
1-480704-0 MALE CONN.
350536 TERM.(F)(14-20)
(1) 18 GRN (AFH)
(2) OPEN
(3) 18 GRAY (AFL)
(4) 18 YEL (CMPON)
(5) 18 WHT/BLK (AHT)
(6) 18 BLK (GND)

6"

 
- 3**
EVAPORATOR FIN T-STAT
T:2-520183-2
18 YEL (CMPON)
18 YEL/RED (CMPREQ)

USAGE:


1 HARNESS PER AC w/HEAT PUMP UNIT
LEGACY, BERKSHIRE, BERKSHIRE XL & BERKSHIRE XLT

NOTE:

1. ALL WIRE TO BE GXL OR EQUIVILENT.
2. ALL SPLICES TO BE COVERED WITH APPROPRIATE HEAT SHRINK.
3. "WHITE" LOOM SIGNIFIES LOW TEMP TUBING REQUIREMENT.
4. "BLUE" LOOM SIGNIFIES HIGH TEMP TUBING REQUIREMENT.
5. HARNESS LENGTHS ARE IN FEET UNLESS NOTED WITH QUOTATION FOR INCHES.
7.  TAG HARNESS WITH MODEL AND PART NUMBER.
8. ²⁶/₁₀₀ FLAT PHONE POSITIONS (1) BLU(2)YEL(3)GRN(4)RED(5)BLK(6)WHT



TOLERANCES ON MACHINED PARTS.				DRAWN: R. DYE		DATE 6/8/18	
INCHES		METRIC		MATERIAL: GXL or Equiv.			
.XX ± .05 .XXX ± .03		X .3mm .XX 10mm		APPLICATION: Electrical			
MODEL(S): ALL		FLOORPLAN(S): ALL/----		PRINT LOCATION: SYSTEMS			
DO NOT SCALE DRAWING				THIS DOCUMENT IS THE PROPERTY OF FOREST RIVER INC. UNAUTHORIZED USE OR DISCLOSURE OF INFORMATION HEREIN IS STRICTLY PROHIBITED.			
SIZE				TITLE			
				A/C & M.PLEX, HRN WHP			
DWG/PRINT NUMBER: 0610-500369.dwg				REV: A			
				SHEETS: 1 / 1			

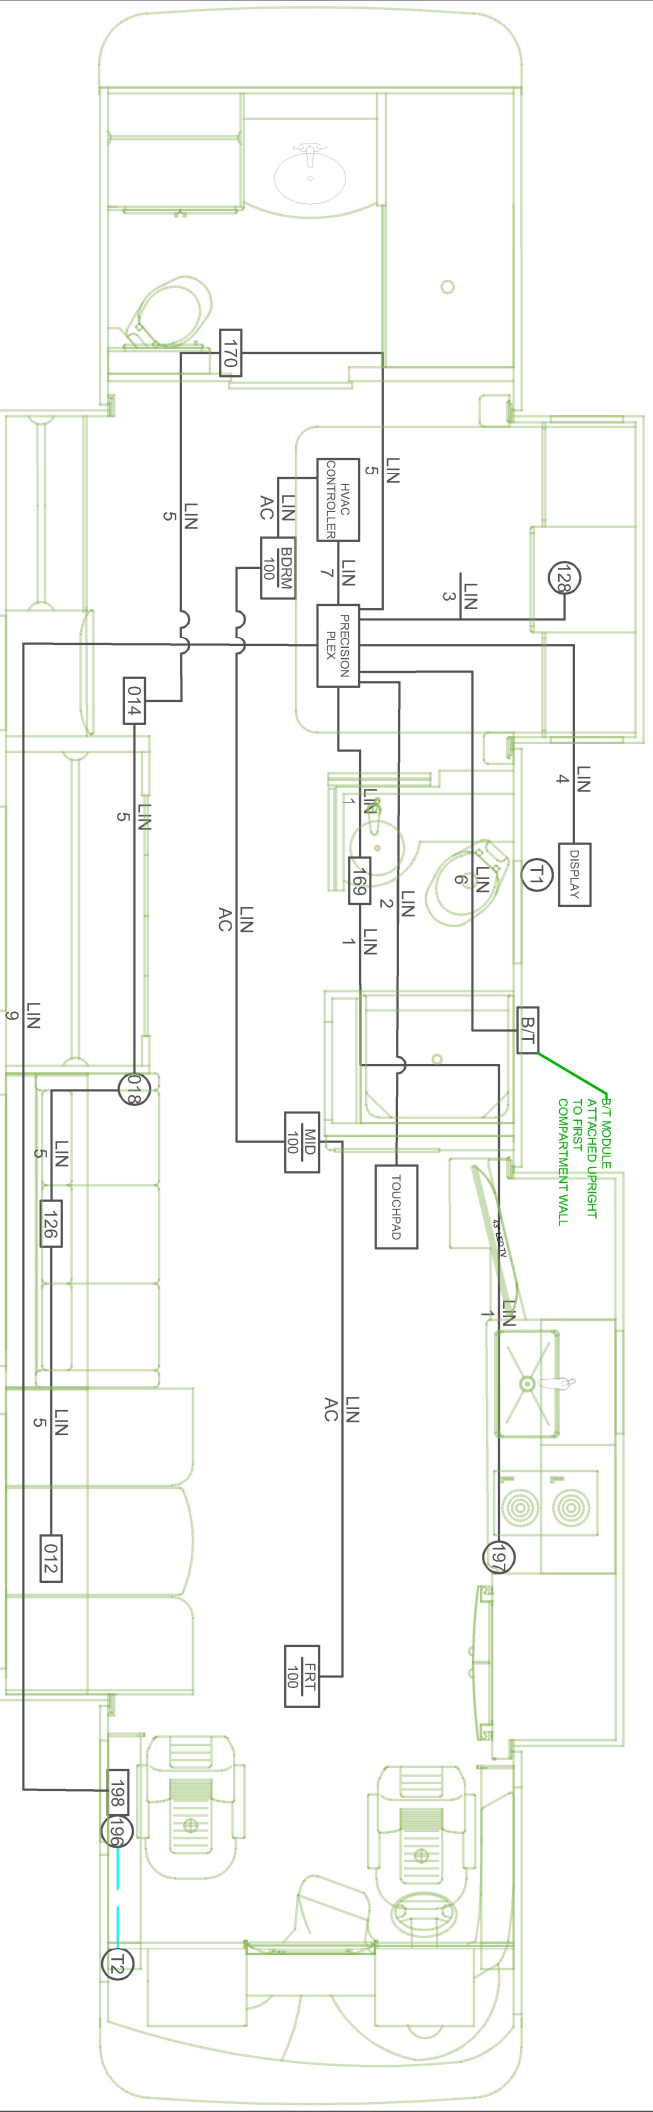

(2021) MULTI PLEX PART LIST		
QTY	DESCRIPTION (STD)	PreciCir PIN
1	7" TOUCH SCREEN	00-10054A005
1	PRECISION PLEX MASTER PANEL	00-10073-000
1	50 AMP PNL w/PCS	00-10020-370
3	110V RELAY (1.BickHr/1.FrtV/1.FtH)	00-10026-200
-	LIN BUS SPLITTER	12-00038-100
-	LIN BUS COUPLER	TBD
3	TANK PROBE MODULE, AC	00-10011-200
1	TANK BAY DISPLAY	00-10051-320
3	HVAC MODULE (H SIG) 1AC	00-10056-100
2	THM NUGGET 1.HVAC/1.AMB/1.TNK	00-10075-000
1	BLUETOOTH MODULE	00-10053-000
SWITCHES		
1	DINETTE SW PNL	00-10066-012
-	DR AWNING SW PNL	00-10066-013
-	BDRM WALL SW PNL	00-10066-014
-	LAV SW PNL	00-10066-015

(2021) MULTI PLEX PART LIST		
QTY	DESCRIPTION (STD)	PreciCir PIN
-	KIT/LR WALL SW PNL	00-10066-016
-	2 BTN AWN SW PNL	00-10066-017
1	HALL WALL SW PNL	00-10066-018
-	KITCHEN SW PNL 2	00-10066-019
-	TV LIFT SW PNL	00-10066-023
-	BATH 2ND DR SW	00-10066-029
3	CLST LTR/SLK HTR	00-10066-039
-	S/O SOFA 1/2 Button Replaces -126	00-10066-040
-	PASS CONSOLE PNL	00-10066-042
1	S/O SOFA 2 (2 Button -141 w/o Wall L)	00-10066-043
1	SOFA O/H SW PNL	00-10067-126
-	4 BTN AWN SW PNL	00-10067-131
-	2ND SOFA SW PNL	00-10067-141
-	3RD SOFA SW PNL	00-10067-143
-	SHARED BATH SW PNL (3/4 ONLY)	00-10067-187
1	BED O/H SW PNL	00-10068A128


(2021) MULTI PLEX PART LIST		
QTY	DESCRIPTION (STD)	PreciCir PIN
-	SOFA SW PNL (LR ACCENT)	00-10068-159
1	BATH 1 SW PNL (W/THRM)	00-10068-169
1	BATH 2 SW PNL (W/THRM)	00-10068-170
-	BATH 2ND WALL SW (6 BTN)	00-10068-195
1	KIT WALL SW PNL (Replaces 125)	00-10071-197
1	6 BTN AWN SW PNL (2X3) (Replaces 127)	00-10072-196
1	ENTRY SW PNL (2X3) (Replaces 130)	00-10072-198
MISCELLANEOUS		
-	PCI Battery Isolation Manager (160Amp)	00-10041-200
1	PCI Battery Isolation Manager (225Amp)	00-10041-252
1	PCI Battery Disconnect (160 Amp)	00-10041-100
-	PCI Battery Disconnect (225 Amp)	00-10041-150
-	110V SHARE SW (OPT)	00-10031-000

HVAC LAYOUT		
DISPLAY INFO	DEVICE	THERMISTOR
BEDROOM	REAR AC	128
LIVING ROOM	HYD HEAT ZONE 2	018
KITCHEN	MID-SHIP AC	018
FRONT AC	FRONT AC	197
HYD HEAT ZONE 1	HYD HEAT ZONE 1	197
COMPARTMENT	HEAT PAQS	11
OUTSIDE	AMBIENT AIR TEMP	T2 (198)

TOLERANCES ON MACHINED PARTS.		DRAWN: R. DYE		DATE: 1/3/22	
INCHES	METRIC	ALL OTHER PARTS AND ASSEMBLY TOLERANCES SHOULD BE HELD AS CLOSE AS POSSIBLE.	MATERIAL Code	PRINT LOCATION SYSTEMS	
XXX ± .05	X .3mm		APPLICATION Electrical	DO NOT SCALE DRAWING	
XXX ± .03	XX .10mm				
MODEL(S): BERKSHIRE, BERKSHIRE XL, BERKSHIRE XLT, CHARLESTON			FLOOR PLAN(S): 40E_LIN		
USAGE OF THE INFORMATION CONTAINED ON THIS DOCUMENT IS CONTINGENT ON AGREEMENT TO THE CONDITIONS STATED ON PAGE 1.					
DWG/PRINT NUMBER: 0620-500938.dwg			TITLE Forest River Inc Diesel Motor Home Division mPlex Layout, 40E_LIN		
REV: E			PAGE: 12 / 23		

OPERATION: PUSH BUTTON LED ON=LATCH RELEASED

REVISION			
REV	ECN	DESCRIPTION	DATE
A		Revised Functionality	5/29/2019
B		Revise Harness Connections & Operation Block	6/24/2020
			AUTHOR
			RED

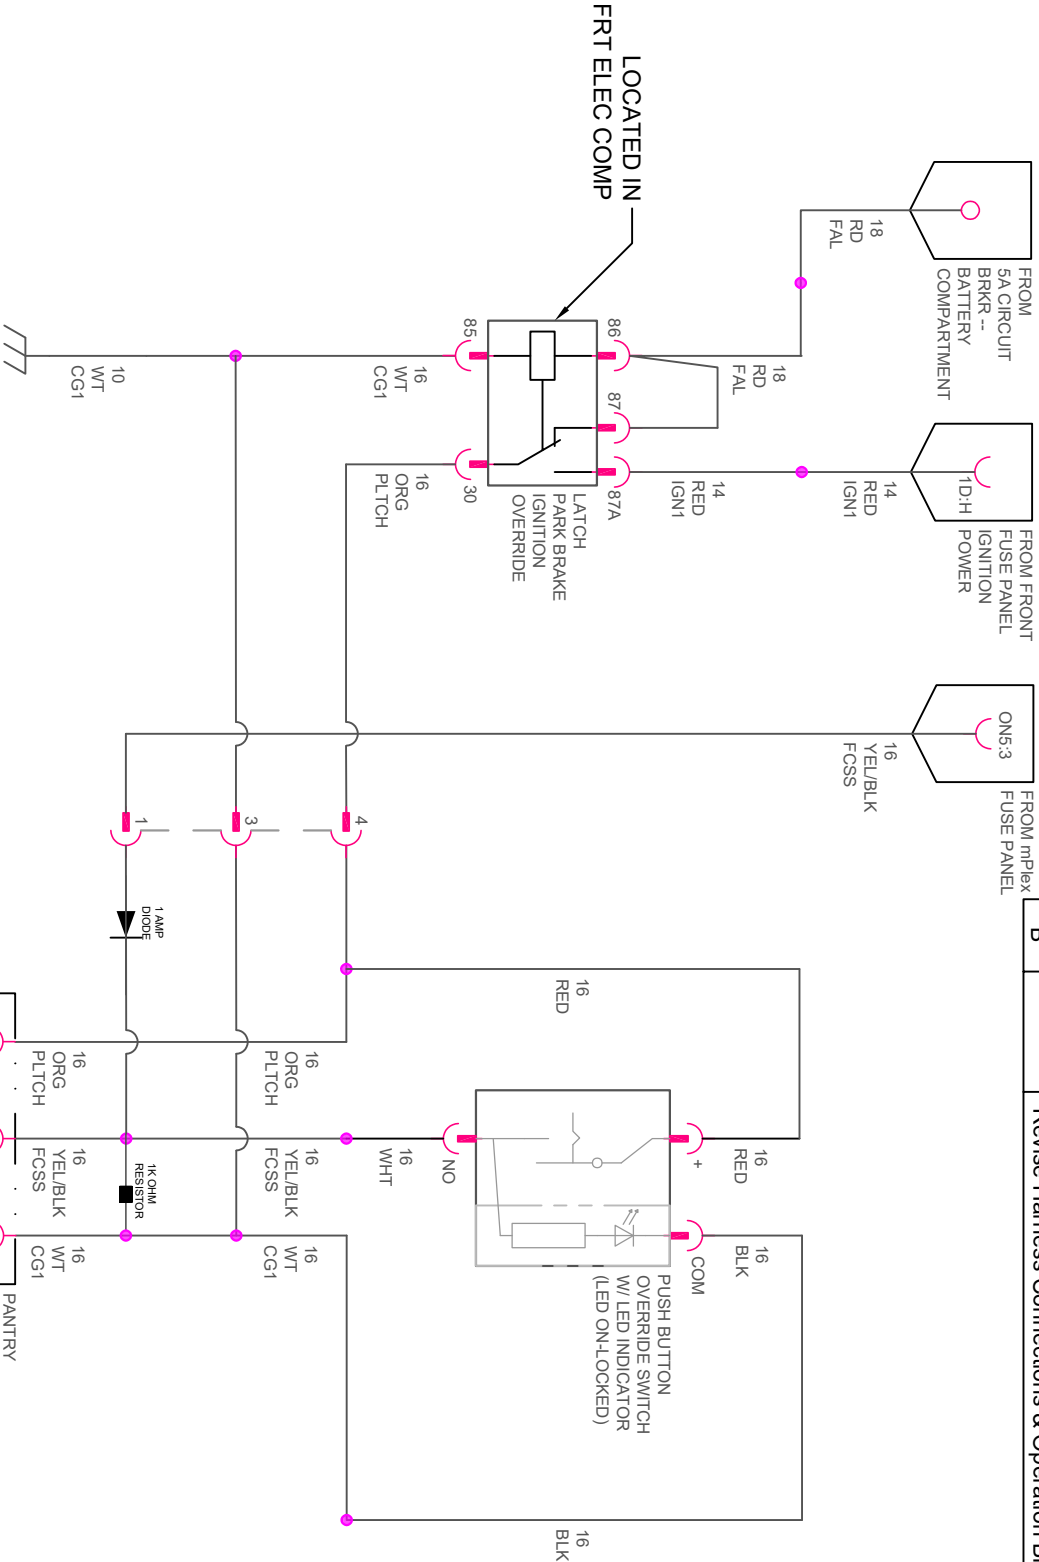

NOTE: FOR GROUND & CONNECTOR LOCATION
REFERENCE APPROPRIATE HARNESS PRINT


PANTRY LATCH & PUSH BUTTON SWITCH LED OPERATION				
House Disconnect	Ignition	Park Brake	Push Button State	Push Button LED
OFF	OFF	SET	RELEASED	OFF
OFF	ON	SET	RELEASED	OFF
OFF	ON	SET	DEPRESSED	ON
OFF	ON	RELEASED	RELEASED	OFF
OFF	ON	RELEASED	DEPRESSED	ON
ON	ON	SET	RELEASED	ON
ON	ON	SET	RELEASED	ON
ON	OFF	SET	RELEASED	ON
ON	ON	RELEASED	RELEASED	OFF
ON	ON	RELEASED	DEPRESSED	ON

TOLERANCES ON MACHINED PARTS:			DRAWN: R. DYE		DATE: 1/3/22	
INCHES	METRIC	ALL OTHER PARTS AND ASSEMBLIES SHOULD BE HELD AS CLOSE AS POSSIBLE.	MATERIAL CODE	REMT LOCATION: SYSTEMS	TITLE: FOREST RIVER INTEL MOTOR HOME DIVISION SCHEMATIC, PANTRY LATCH	
.XX ± .05 .XXX ± .03	.X .3mm .XX 10mm		APPLICATION: Electrical	DO NOT SCALE DRAWING		
MODEL(S): BERSHIRE, XL, XLT			FLOORPLAN(S): ALL, ---, ---, ---, ---			
USAGE OF THE INFORMATION CONTAINED ON THIS DOCUMENT IS CONTINGENT ON AGREEMENT TO THE CONDITIONS STATED ON PAGE 1.						
DWG/PRINT NUMBER: 0630-500705.dwg			REV: B			
SHEETS: 2 / 2						

A/C LEGEND

DESCRIPTION	SYMBOL	DESCRIPTION	SYMBOL	DESCRIPTION	SYMBOL
120V DUPLEX RCPT		DISTRIBUTION PNL		FREEZER	
120V GFCI RCPT		MICROWAVE		GENERATOR	
120V SINGLE RCPT		POWER CORD		ENERGY MGMT SYS.	
120V GFCI BLANK		AIR CONDITIONER		120V SHARE SWITCH	
INVERTER/CONV.		VACUUM		TRANSFER SWITCH	
JUNCTION BOX		COOKTOP			
NOTE: 6-3 W/GND ROMEX FOR 50A MAIN					
10-2 W/GND ROMEX FOR MAIN 30A CIRCUIT (INVERTER)					
12-2 W/GND ROMEX FOR MAIN 20A CIRCUITS					
14-2 W/GND ROMEX FOR MAIN 15A CIRCUITS (WHT-STD / GRN-GFI / BLK- FIREPLACE)					
MAGNUM ENERGY PURE-SINE WAVE INVERTER/ CHARGER MODEL: MS2812-F 3kW / 125A					
ZZ40 QAI, ALL CIRCUITS 15A UNLESS GREATER IS REQUIRED BY APPLANCE MANIF.					

DISTRIBUTION PANEL						INVERTER					
50A	50A	20A	20A	20A	15A	20A	15A	15A	20A	15A	20A
MAIN	MAIN	1A	FRT FLR HEAT								
		1B	FRT AIR CONDITIONER								
		2A	REAR FLR HEAT								
		2B	REAR AIR CONDITIONER								
		3A	FIREPLACE								
		3B	MID AIR CONDITIONER								
		4A	COOKTOP								
		4B	INVERTER								
		5A	BLOCK HEATER								
		5B	DISHWASHER (OPT)								
		6A	WASHER								
		6B	DRYER								
		7	KITCHEN & GEN RECEPTS								
		8A	GEN RECEPTS								
8B	REFRIGERATOR										
9A	BATH & GEN RECEPTS										
9B	AQUAHOT										
10A	VACUUM										
10B	MICROWAVE										
BREAKER BOX SHOWN WITH OPTIONAL EQUIPMENT											

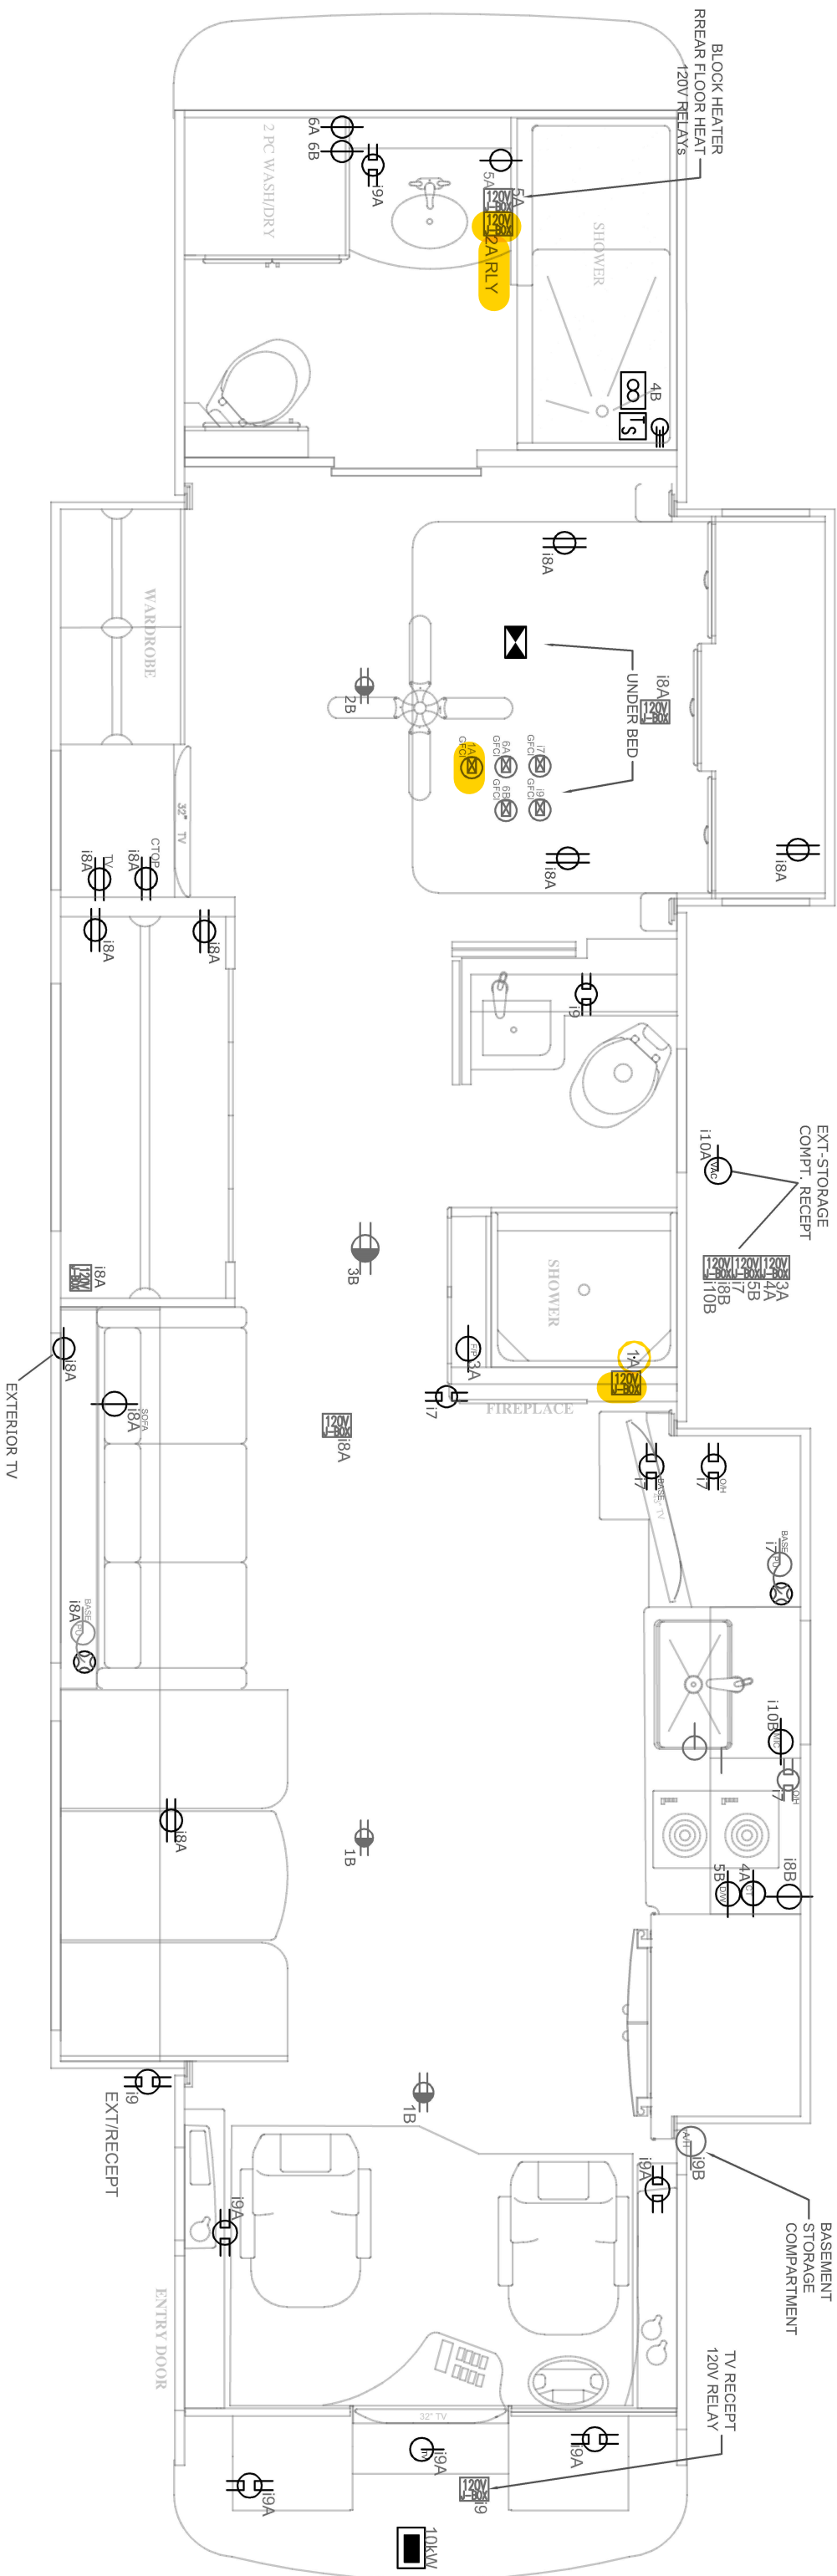

NOTE:

ROMEX LEGEND:


14½ WHT SHEATHING - STANDARD CIRCUITS

14½ BLK SHEATHING - FIREPLACE


¹⁴/₂ GRN SHEATHING - GFI CIRCUITS

12½ YEL SHEATHING - 20A CIRCUITS


TOLERANCES ON MACHINED PARTS.		DRAWN: R. DYE		DATE: 2/28/22	
INCHES	METRIC	ALL OTHER PARTS AND ASSEMBLY TOLERANCES SHOULD BE HELD AS CLOSE AS POSSIBLE.		MATERIAL: Code	PRINT LOCATION: SYSTEMS
.XX ± .05	.X .3mm .XX 10mm			APPLICATION: Electrical	DO NOT SCALE DRAWING
MODEL(S): BERKSHIRE, BERKSHIRE XL, BERKSHIRE XLT, CHARLESTON		FLOOR PLAN(S): 40E		USAGE OF THE INFORMATION CONTAINED ON THIS DOCUMENT IS CONTINGENT ON AGREEMENT TO THE CONDITIONS STATED ON PAGE 1.	
TITLE 120V LAYOUT, 40E					
DWG/PRINT NUMBER: 0620-500952.dwg					
		PAGE: 9 / 14		REV: B	

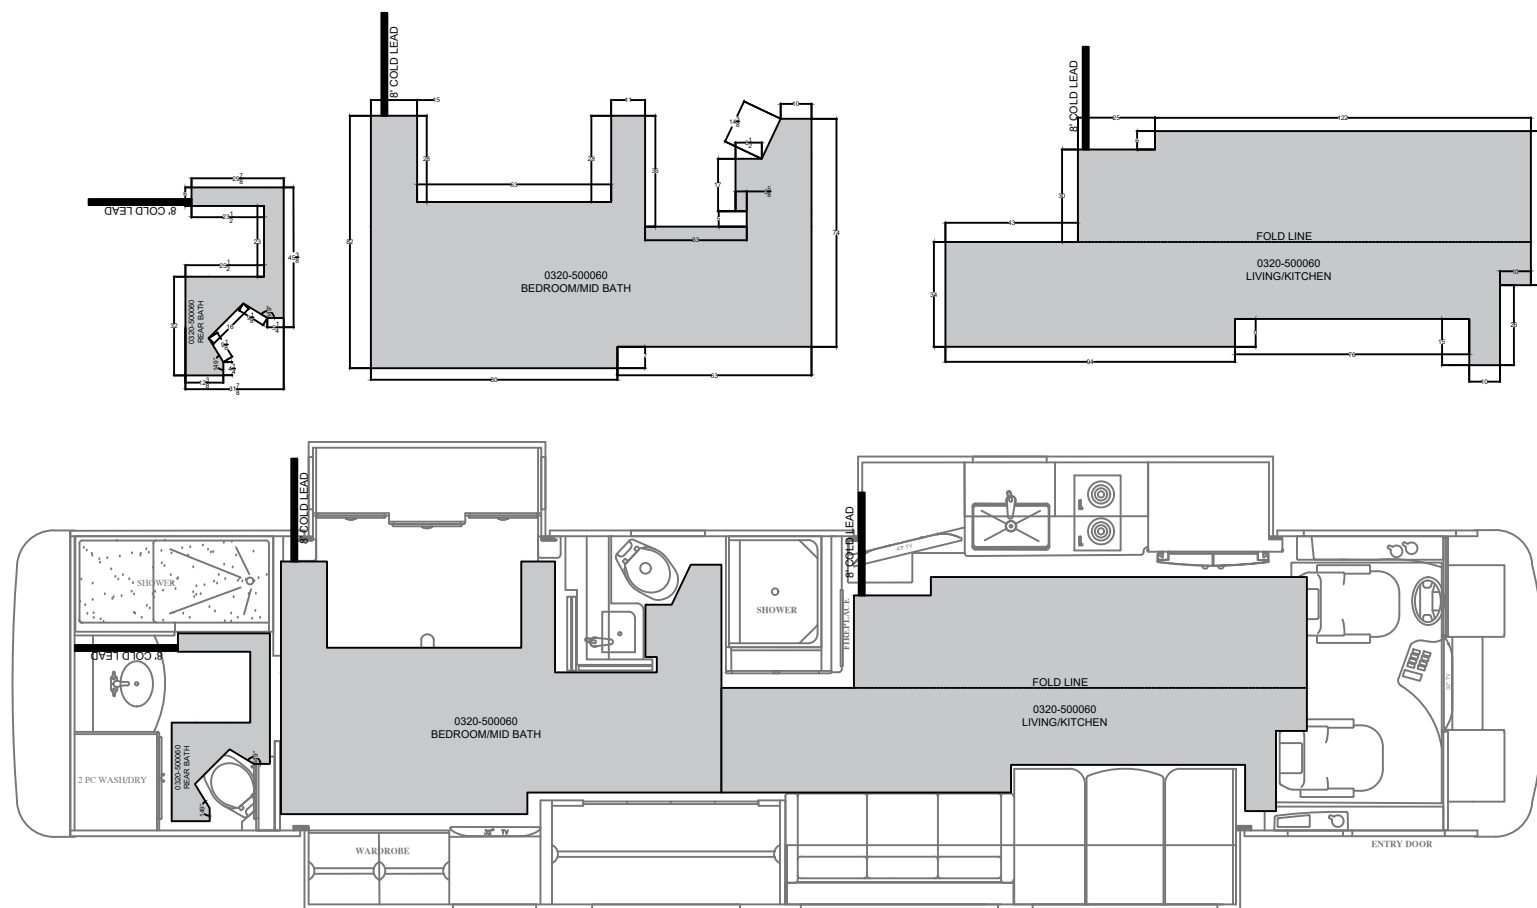


REVISION				
REV	ECN	DESCRIPTION	DATE	AUTHOR
A	2023	ADDED BEDROOM AND BATH	2/23/2022	BBM

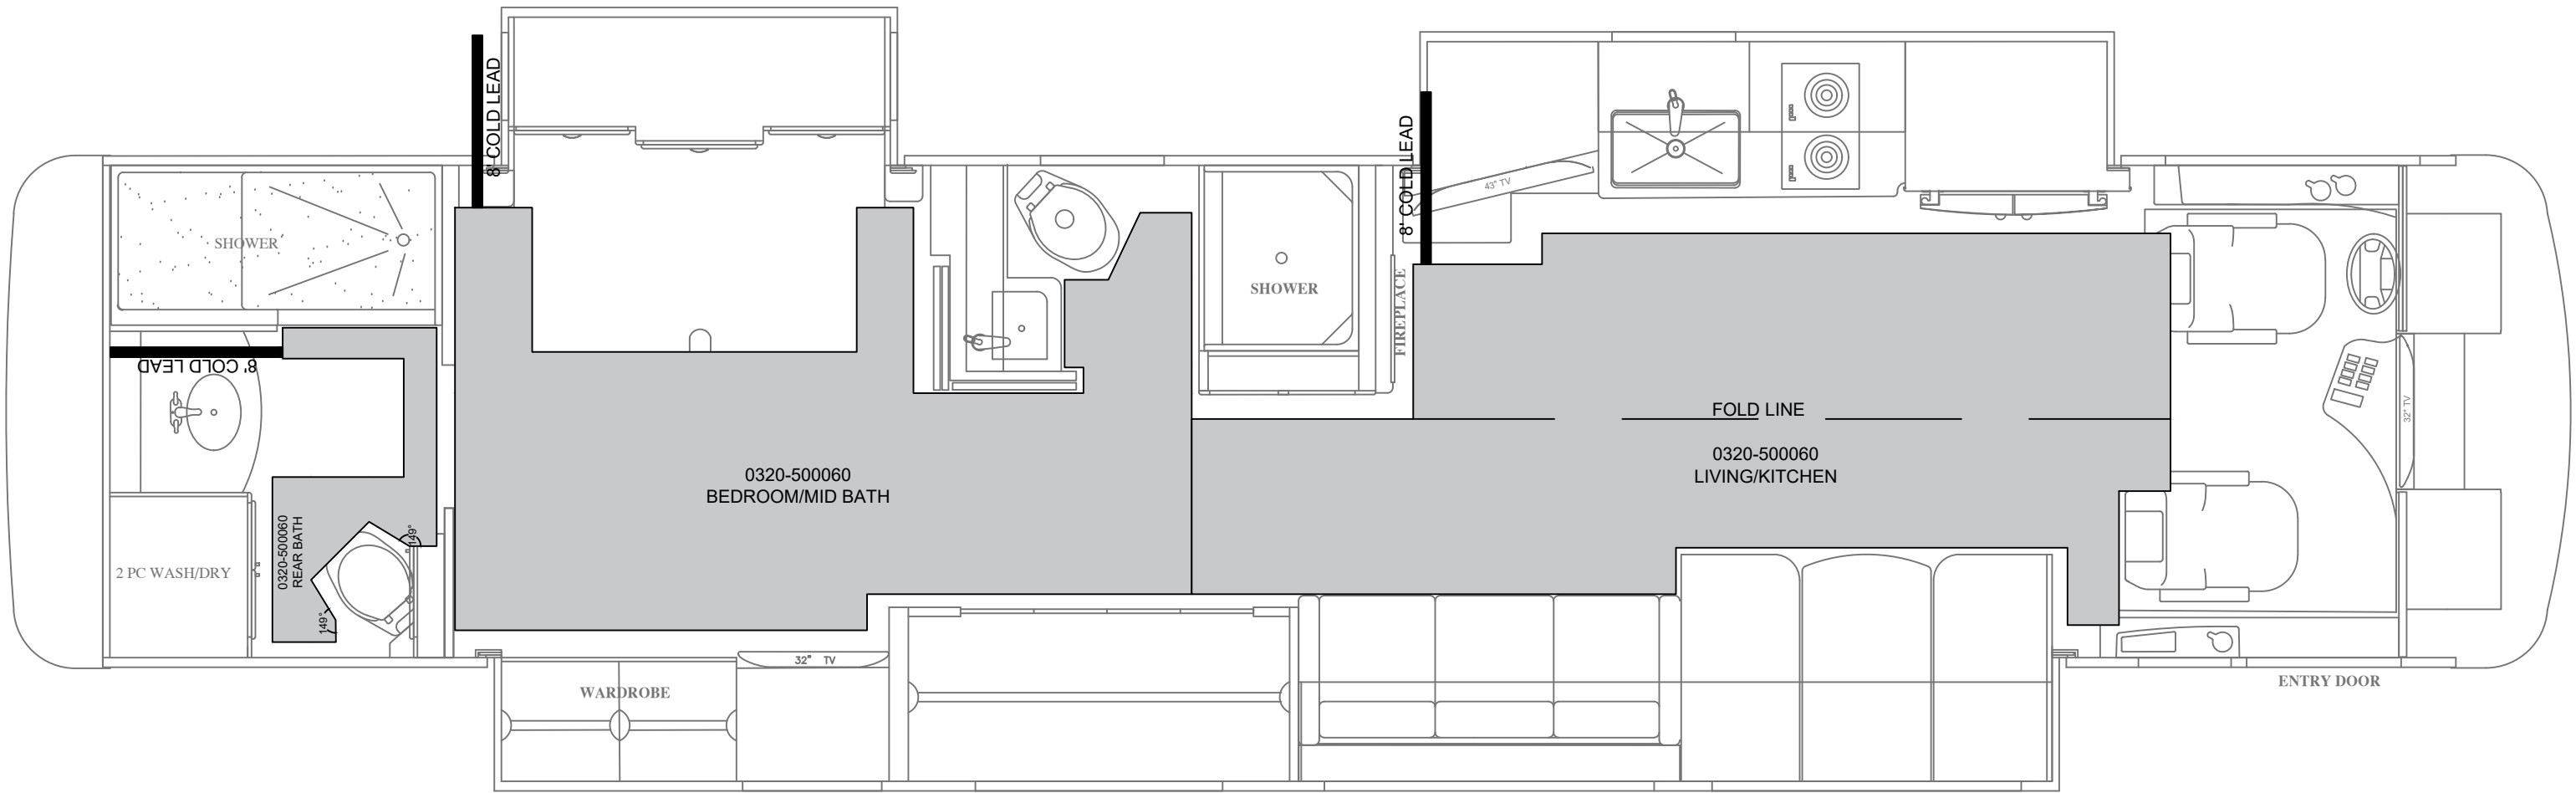

TOLERANCES ON MACHINED PARTS.			DRAWN: BMAIN		DATE 2/28/22		FOREST RIVER DIESEL MOTOR HOME DIVISION			
INCHES	METRIC	ALL OTHER PARTS AND ASSEMBLY TOLERANCES SHOULD BE HELD AS CLOSE AS POSSIBLE.	<u>MATERIAL:</u> Elec Mat							
.XX ± .05 .XXX ± .03	.X .3mm .XX 10mm		<u>APPLICATION:</u> Electrical							
MODEL(S): BERKSHIRE XL			FLOORPLAN(S): 40E		<u>PRINT LOCATION:</u> SYSTEMS					
			DO NOT SCALE DRAWING			TITLE HEATED FLR , LAYOUT				
			THIS DOCUMENT IS THE PROPERTY OF FOREST RIVER INC.UNAUTHORIZED USE OR DISCLOSURE OF INFORMATION HEREIN IS STRICTLY PROHIBITED.			SIZE	DWG/PRINT NUMBER: 0320-500060.dwg			REV: A
								SHEETS: 1 / 4		

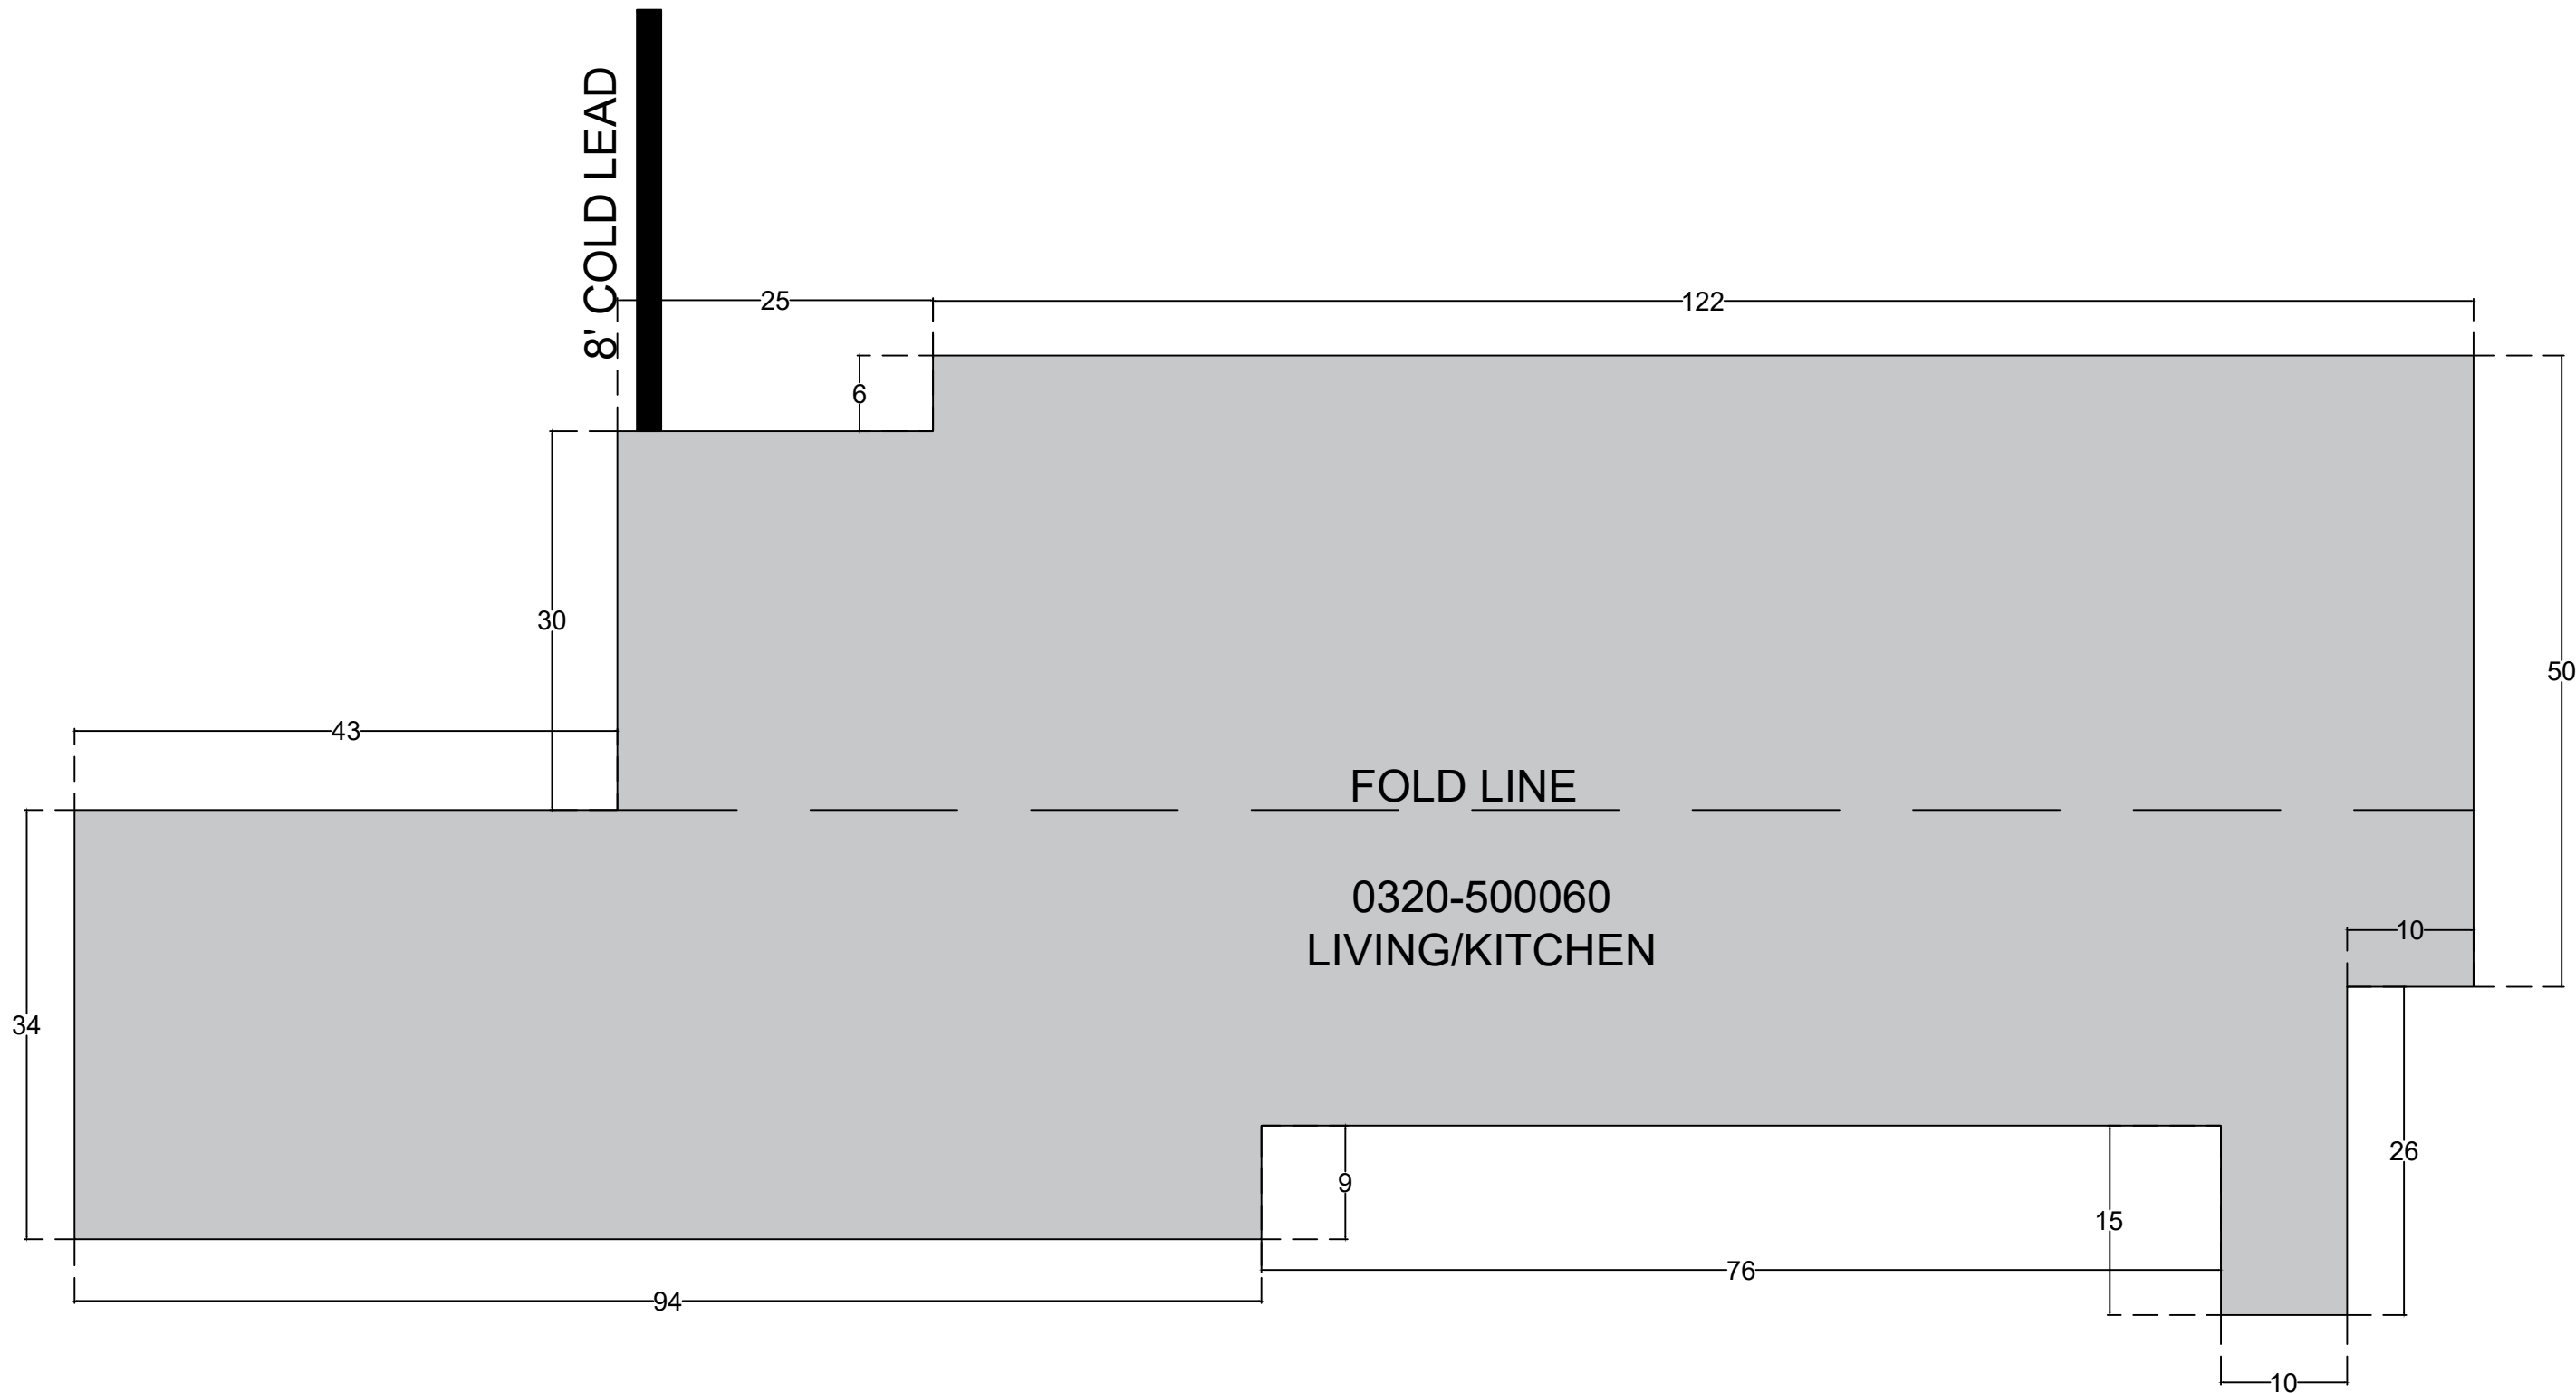


TOLERANCES ON MACHINED PARTS.			DRAWN: BMAIN		DATE 2/28/22		FOREST RIVER DIESEL MOTOR HOME DIVISION			
INCHES	METRIC	ALL OTHER PARTS AND ASSEMBLY TOLERANCES SHOULD BE HELD AS CLOSE AS POSSIBLE.	<u>MATERIAL:</u> Electric Mat							
.XX ± .05 .XXX ± .03	.X .3mm .XX 10mm		<u>APPLICATION:</u> Electrical							
MODEL(S): BERKSHIRE XL			FLOORPLAN(S): 40E		<u>PRINT LOCATION:</u> SYSTEMS		TITLE HEATED FLR , LIVRM			
DO NOT SCALE DRAWING				SIZE		DWG/PRINT NUMBER: 0320-500060.dwg				
THIS DOCUMENT IS THE PROPERTY OF FOREST RIVER INC.UNAUTHORIZED USE OR DISCLOSURE OF INFORMATION HEREIN IS STRICTLY PROHIBITED.								SHEETS: 2 / 4		

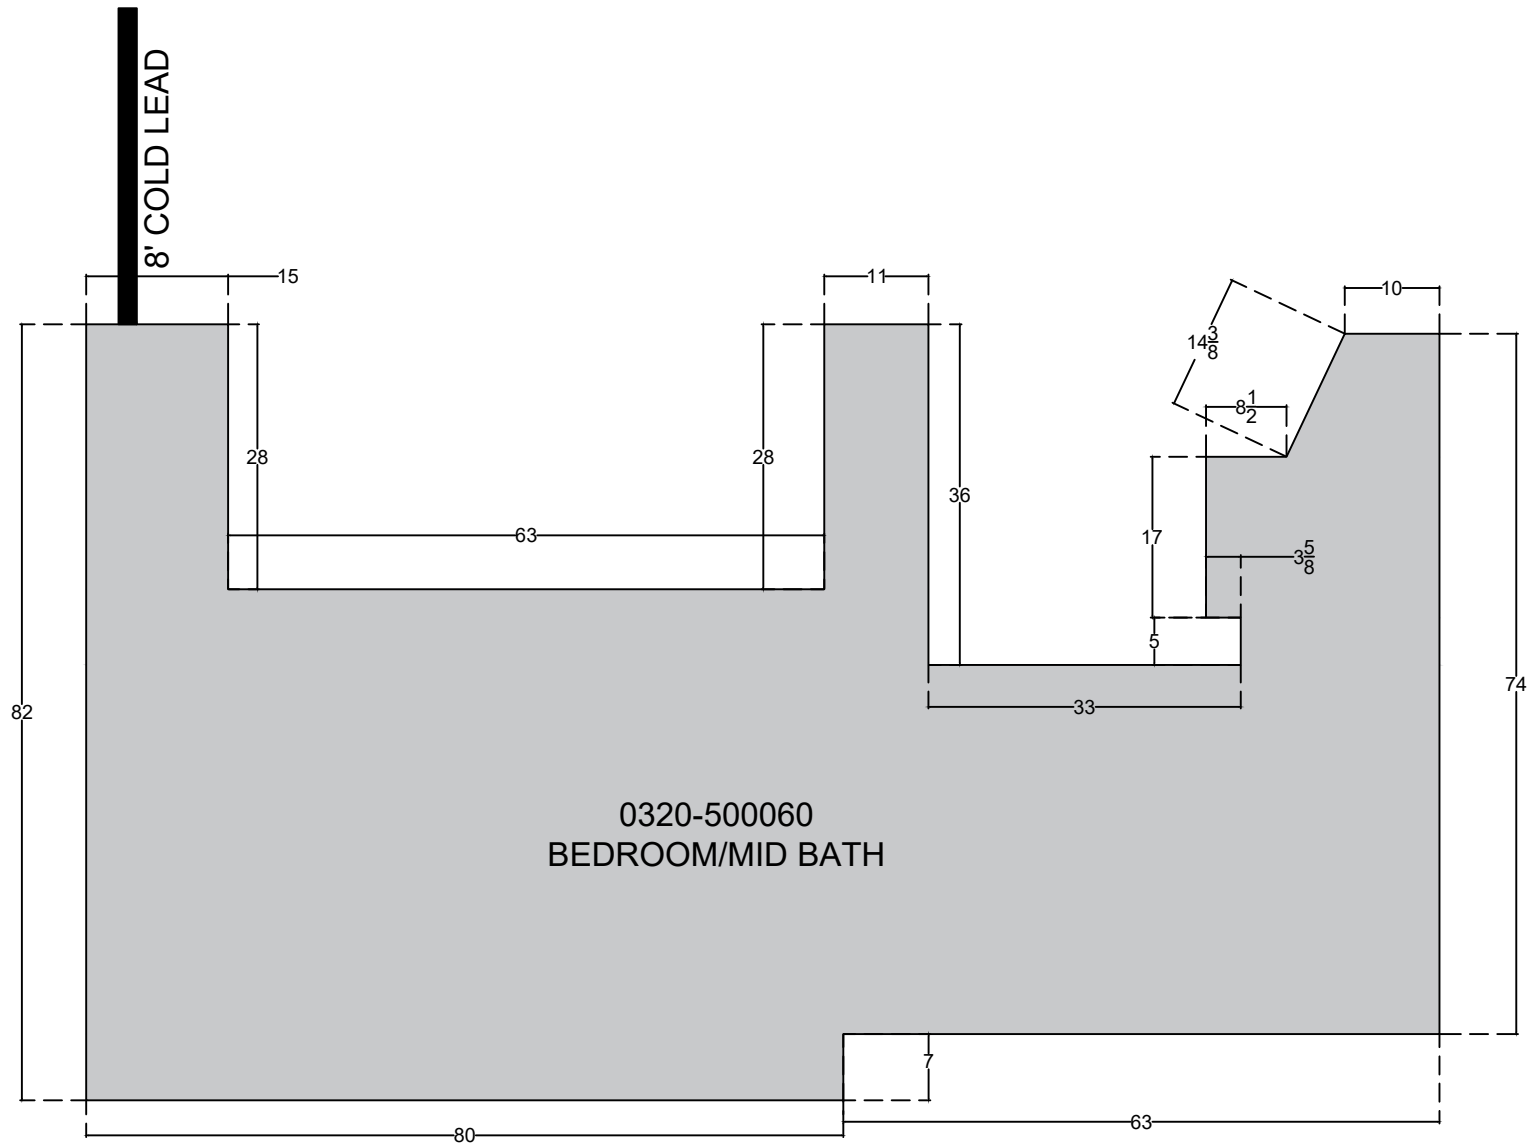

0320-500060
BEDROOM/MID BATH


TOLERANCES ON MACHINED PARTS.			DRAWN: BMAIN		DATE 2/28/22		FOREST RIVER DIESEL MOTOR HOME DIVISION		
INCHES	METRIC	ALL OTHER PARTS AND ASSEMBLY TOLERANCES SHOULD BE HELD AS CLOSE AS POSSIBLE.	<u>MATERIAL:</u> Electric Mat						
.XX ± .05 .XXX ± .03	.X .XX .3mm 10mm		<u>APPLICATION:</u> Electrical						
MODEL(S): BERKSHIRE XL			<u>PRINT LOCATION:</u> SYSTEMS						
FLOORPLAN(S): 40E		DO NOT SCALE DRAWING			SIZE	DWG/PRINT NUMBER: 0320-500060.dwg			
		THIS DOCUMENT IS THE PROPERTY OF FOREST RIVER INC. UNAUTHORIZED USE OR DISCLOSURE OF INFORMATION HEREIN IS STRICTLY PROHIBITED.				REV: A			
							SHEETS: 4 / 4		

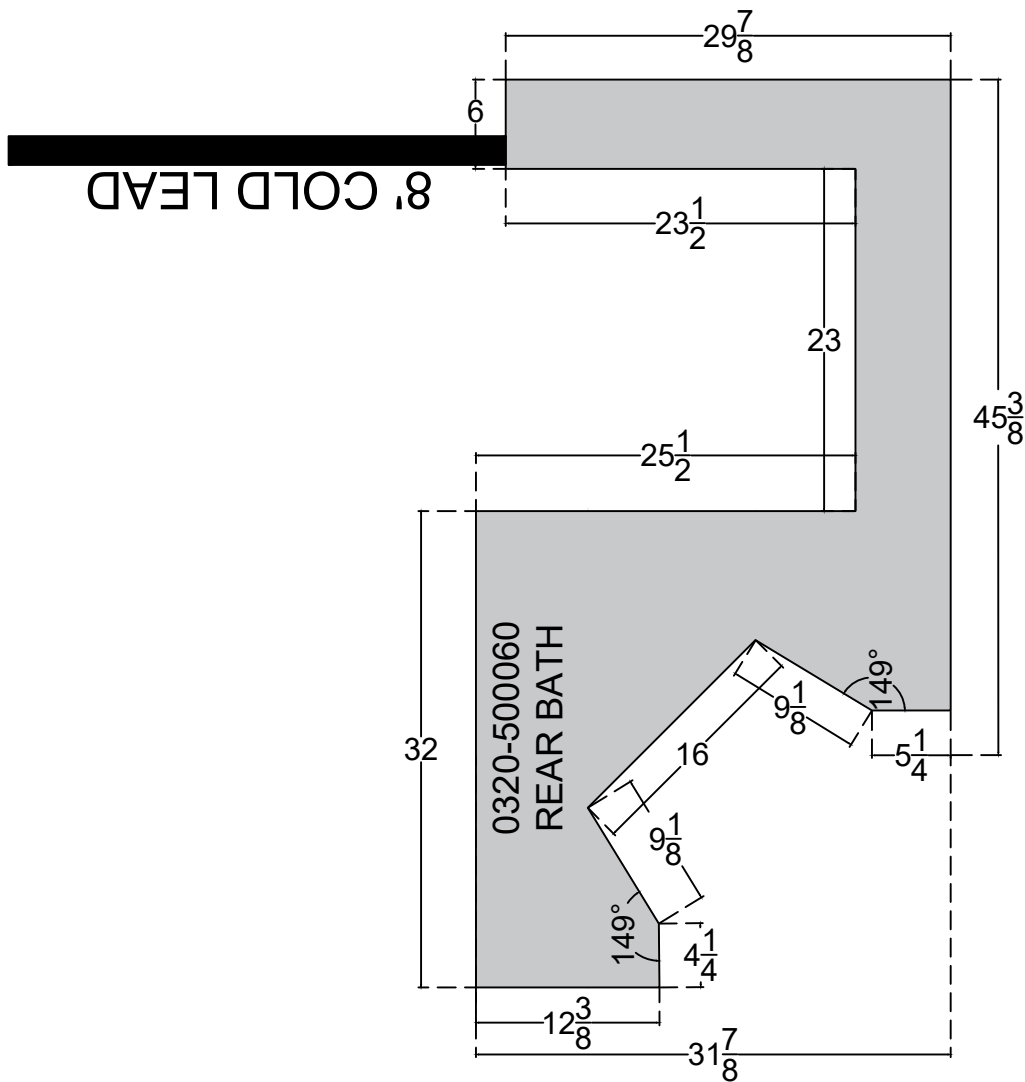

TOLERANCES ON MACHINED PARTS.			DRAWN: BMAIN		DATE 2/28/22		FOREST RIVER DIESEL MOTOR HOME DIVISION			
INCHES	METRIC	ALL OTHER PARTS AND ASSEMBLY TOLERANCES SHOULD BE HELD AS CLOSE AS POSSIBLE.	MATERIAL: Electric Mat		APPLICATION: Electrical					
.XX ± .05	.X .3mm		PRINT LOCATION: ELECTRICAL		TITLE HEATED FLR , REAR MAT					
.XXX ± .03	.XX 10mm		DO NOT SCALE DRAWING		SIZE DWG/PRINT NUMBER: 0320-500060.dwg		REV: A			
MODEL(S): BERKSHIRE XL		FLOORPLAN(S): 40E		THIS DOCUMENT IS THE PROPERTY OF FOREST RIVER INC. UNAUTHORIZED USE OR DISCLOSURE OF INFORMATION HEREIN IS STRICTLY PROHIBITED.						
						SHEETS: 3 / 4				

OPERATION: PUSH BUTTON LED ON=LATCH RELEASED

REVISION			
REV	ECN	DESCRIPTION	DATE
A		Revised Functionality	5/29/2019
B		Revise Harness Connections & Operation Block	6/24/2020
			AUTHOR
			RED

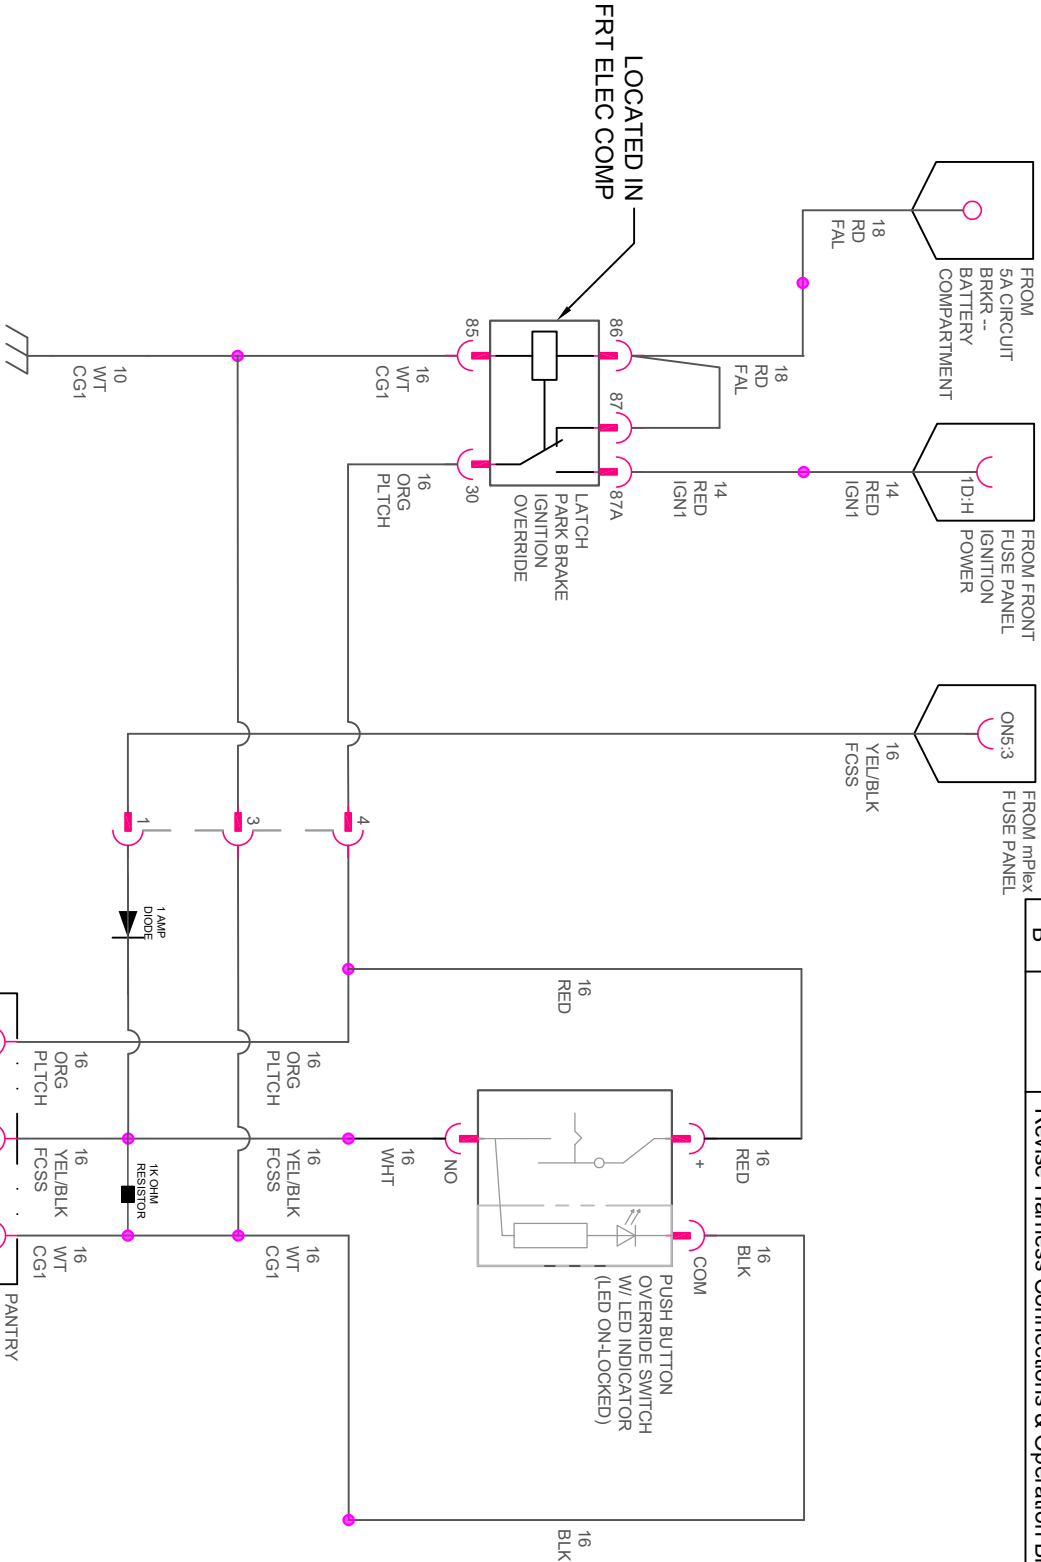


NOTE: FOR GROUND & CONNECTOR LOCATION
REFERENCE APPROPRIATE HARNESS PRINT

PANTRY LATCH & PUSH BUTTON SWITCH LED OPERATION

House Disconnect	Ignition	Park Brake	Push Button State	Push Button LED	Latch State
OFF	OFF	SET	RELEASED	OFF	LOCKED
OFF	ON	SET	DEPRESSED	ON	UNLOCKED
OFF	ON	RELEASED	RELEASED	OFF	LOCKED
OFF	ON	RELEASED	DEPRESSED	ON	UNLOCKED
ON	ON	SET	RELEASED	ON	UNLOCKED
ON	OFF	SET	RELEASED	ON	UNLOCKED
ON	ON	RELEASED	RELEASED	OFF	LOCKED
ON	ON	RELEASED	DEPRESSED	ON	UNLOCKED

TOLERANCES ON MACHINED PARTS:			DRAWN: R. DYE		DATE: 1/3/22	
INCHES	METRIC	ALL OTHER PARTS AND ASSEMBLIES SHOULD BE HELD AS CLOSE AS POSSIBLE.	MATERIAL CODE	BRACKET LOCATION: SYSTEMS	FOREST RIVER DIESEL MOTOR HOME DIVISION SCHEMATIC, PANTRY LATCH	
.XX ± .05	.X .3mm		APPLICATION: Electrical	DO NOT SCALE DRAWING		
.XXX ± .03	.XX 10mm					
MODEL(S): BERSHIRE, XL, XLT		FLOORPLAN(S): ALL, ---, ---, ---				
USAGE OF THE INFORMATION CONTAINED ON THIS DOCUMENT IS CONTINGENT ON AGREEMENT TO THE CONDITIONS STATED ON PAGE 1.						
DWG/PRINT NUMBER: 0630-500705.dwg			REV: B		SHEETS: 2 / 2	

REVISION				
REV	ECN	DESCRIPTION	DATE	AUTHOR
A	NA	ELECTRIC LATCH	9/5/2023	BBM

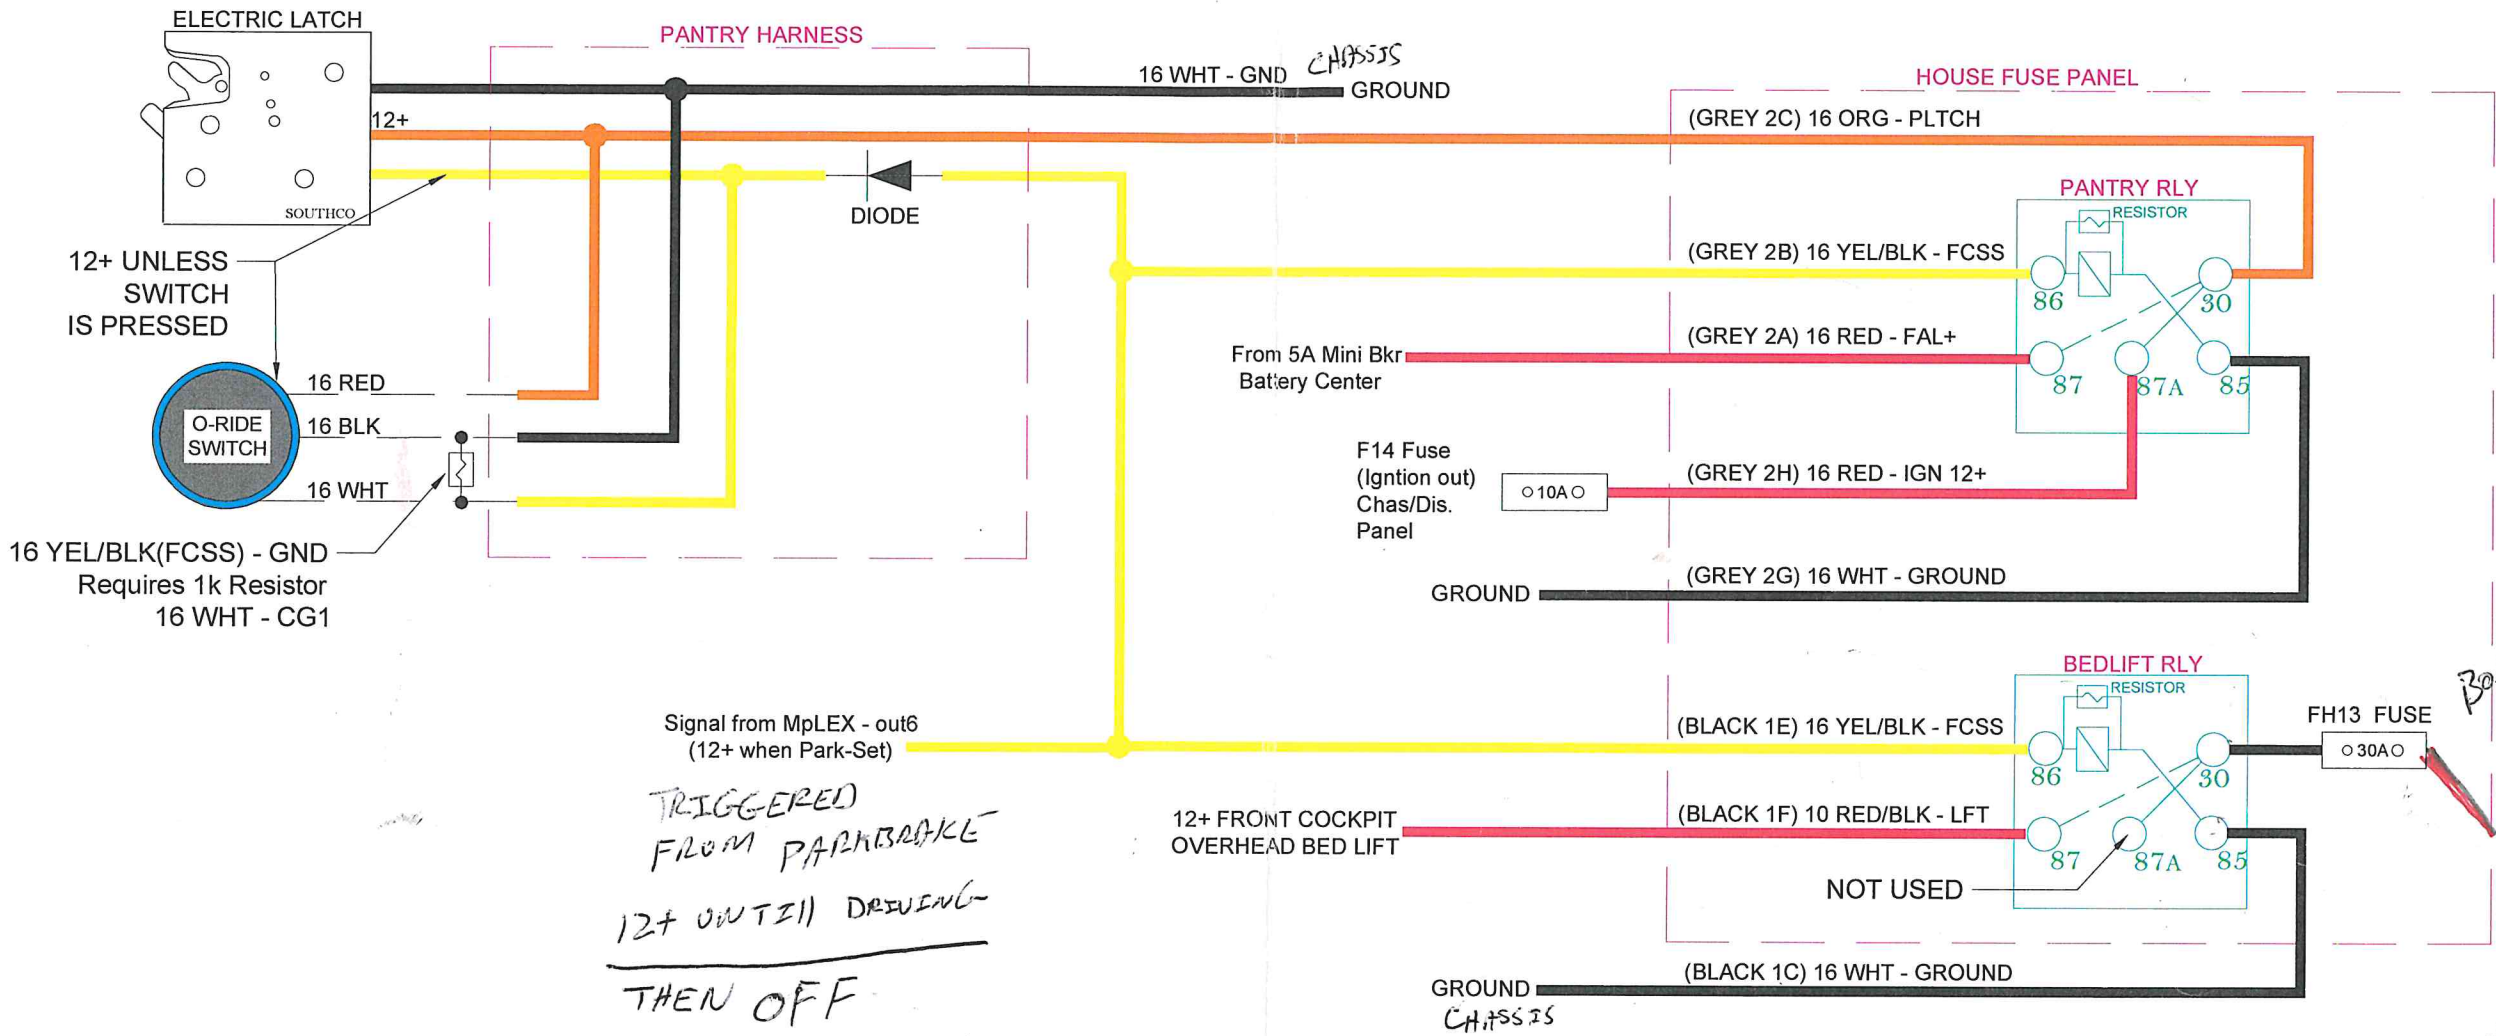

TOLERANCES ON MACHINED PARTS.			DRAWN: BMAIN		DATE 9/5/23		FOREST RIVER DIESEL MOTOR HOME DIVISION					
INCHES	METRIC	ALL OTHER PARTS AND ASSEMBLY TOLERANCES SHOULD BE HELD AS CLOSE AS POSSIBLE.	MATERIAL: GXL OR BETTER			TITLE LATCH,ELEC(PANTRY/DRWR)						
XX ± .05 .XXX ± .03	X .3mm .XX 10mm	APPLICATION: ####										
MODEL(S): ALL		FLOORPLAN(S): VARIES		PRINT LOCATION: #####			SIZE		DWG/PRINT NUMBER: 0620-500966.dwg		REV: A	
				DO NOT SCALE DRAWING								
			THIS DOCUMENT IS THE PROPERTY OF FOREST RIVER INC.UNAUTHORIZED USE OR DISCLOSURE OF INFORMATION HEREIN IS STRICTLY PROHIBITED.					SHEETS: 1/1				

87
House
IGN
87A
G
85
F30

BED HAS BEEN CHANGING 30A FUSE ON PANTRY LINE

BEDLIFT

87
87A
85
30
GRND